
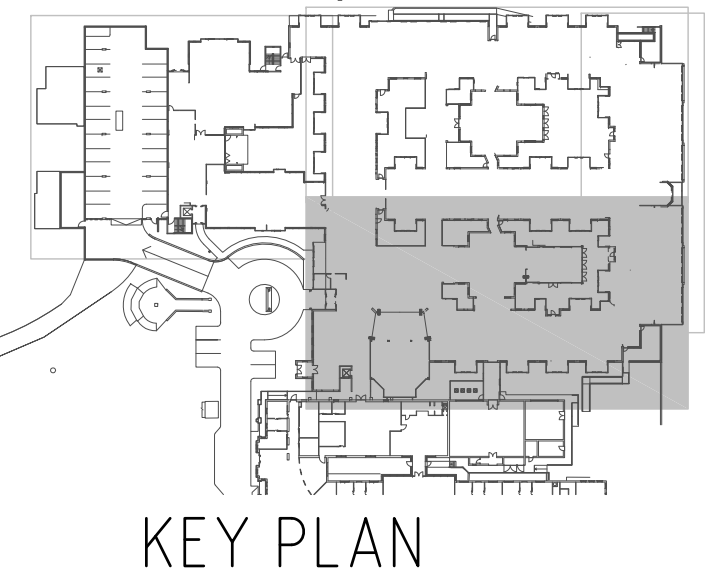


FOR CONTINUATION REFER DWG E105

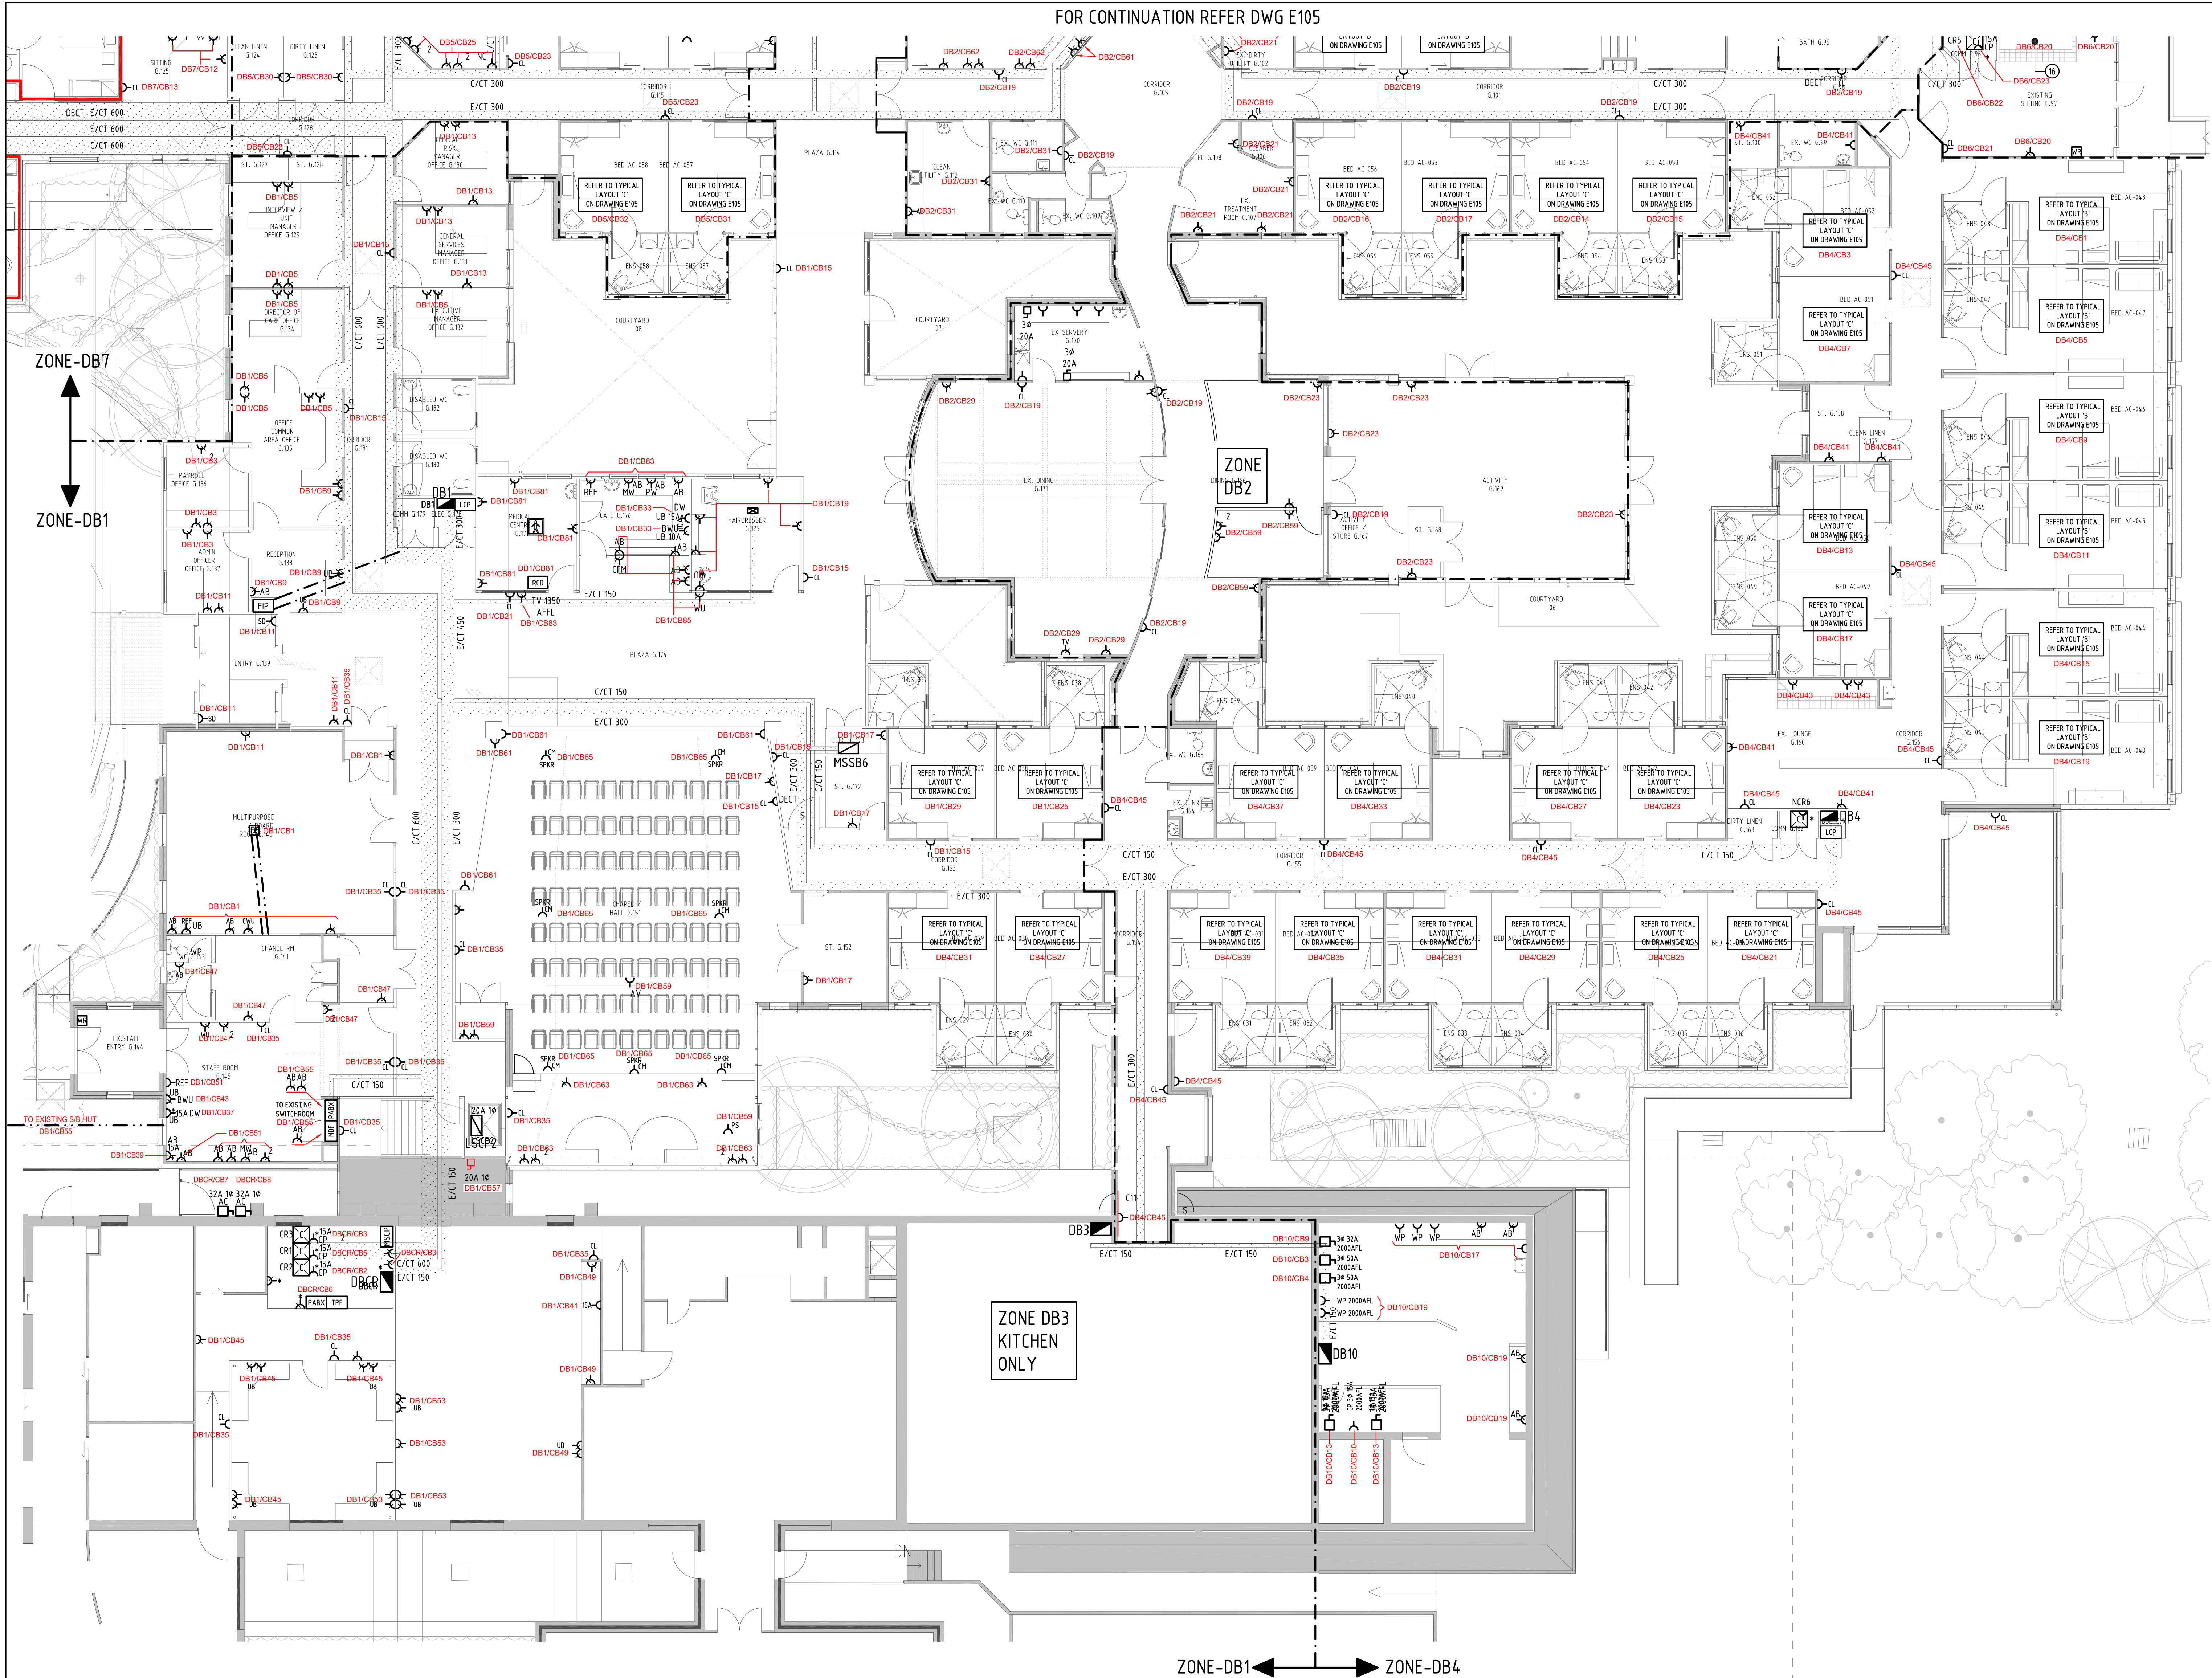

KEY PLAN

AB		AS BUILT - STAGE 3	MF	19.06.14
Rev	Description	By	Date	
<div><div>X STAFF</div><div>X STAFF ELECTRICAL CONTRACTING Ph: 9407 1764 Fax: 9407 1768 email: admin@xstaff.com.au</div></div>				
Project ASSISI CENTRE EXISTING AGED CARE BUILDING & NEW RETIREMENT ACCOMMODATION 230 ROSANNA RD, ROSANNA				
Title ELECTRICAL SERVICES GROUND FLOOR - SHEET 3 POWER LAYOUT STAGE 3				
North	Drawn MF 19/06/13	Checked M.T.	Approved	
Project No. ASSISI		Drawing No. E106		Scale 1:100 @ B1
Revision			AB	